
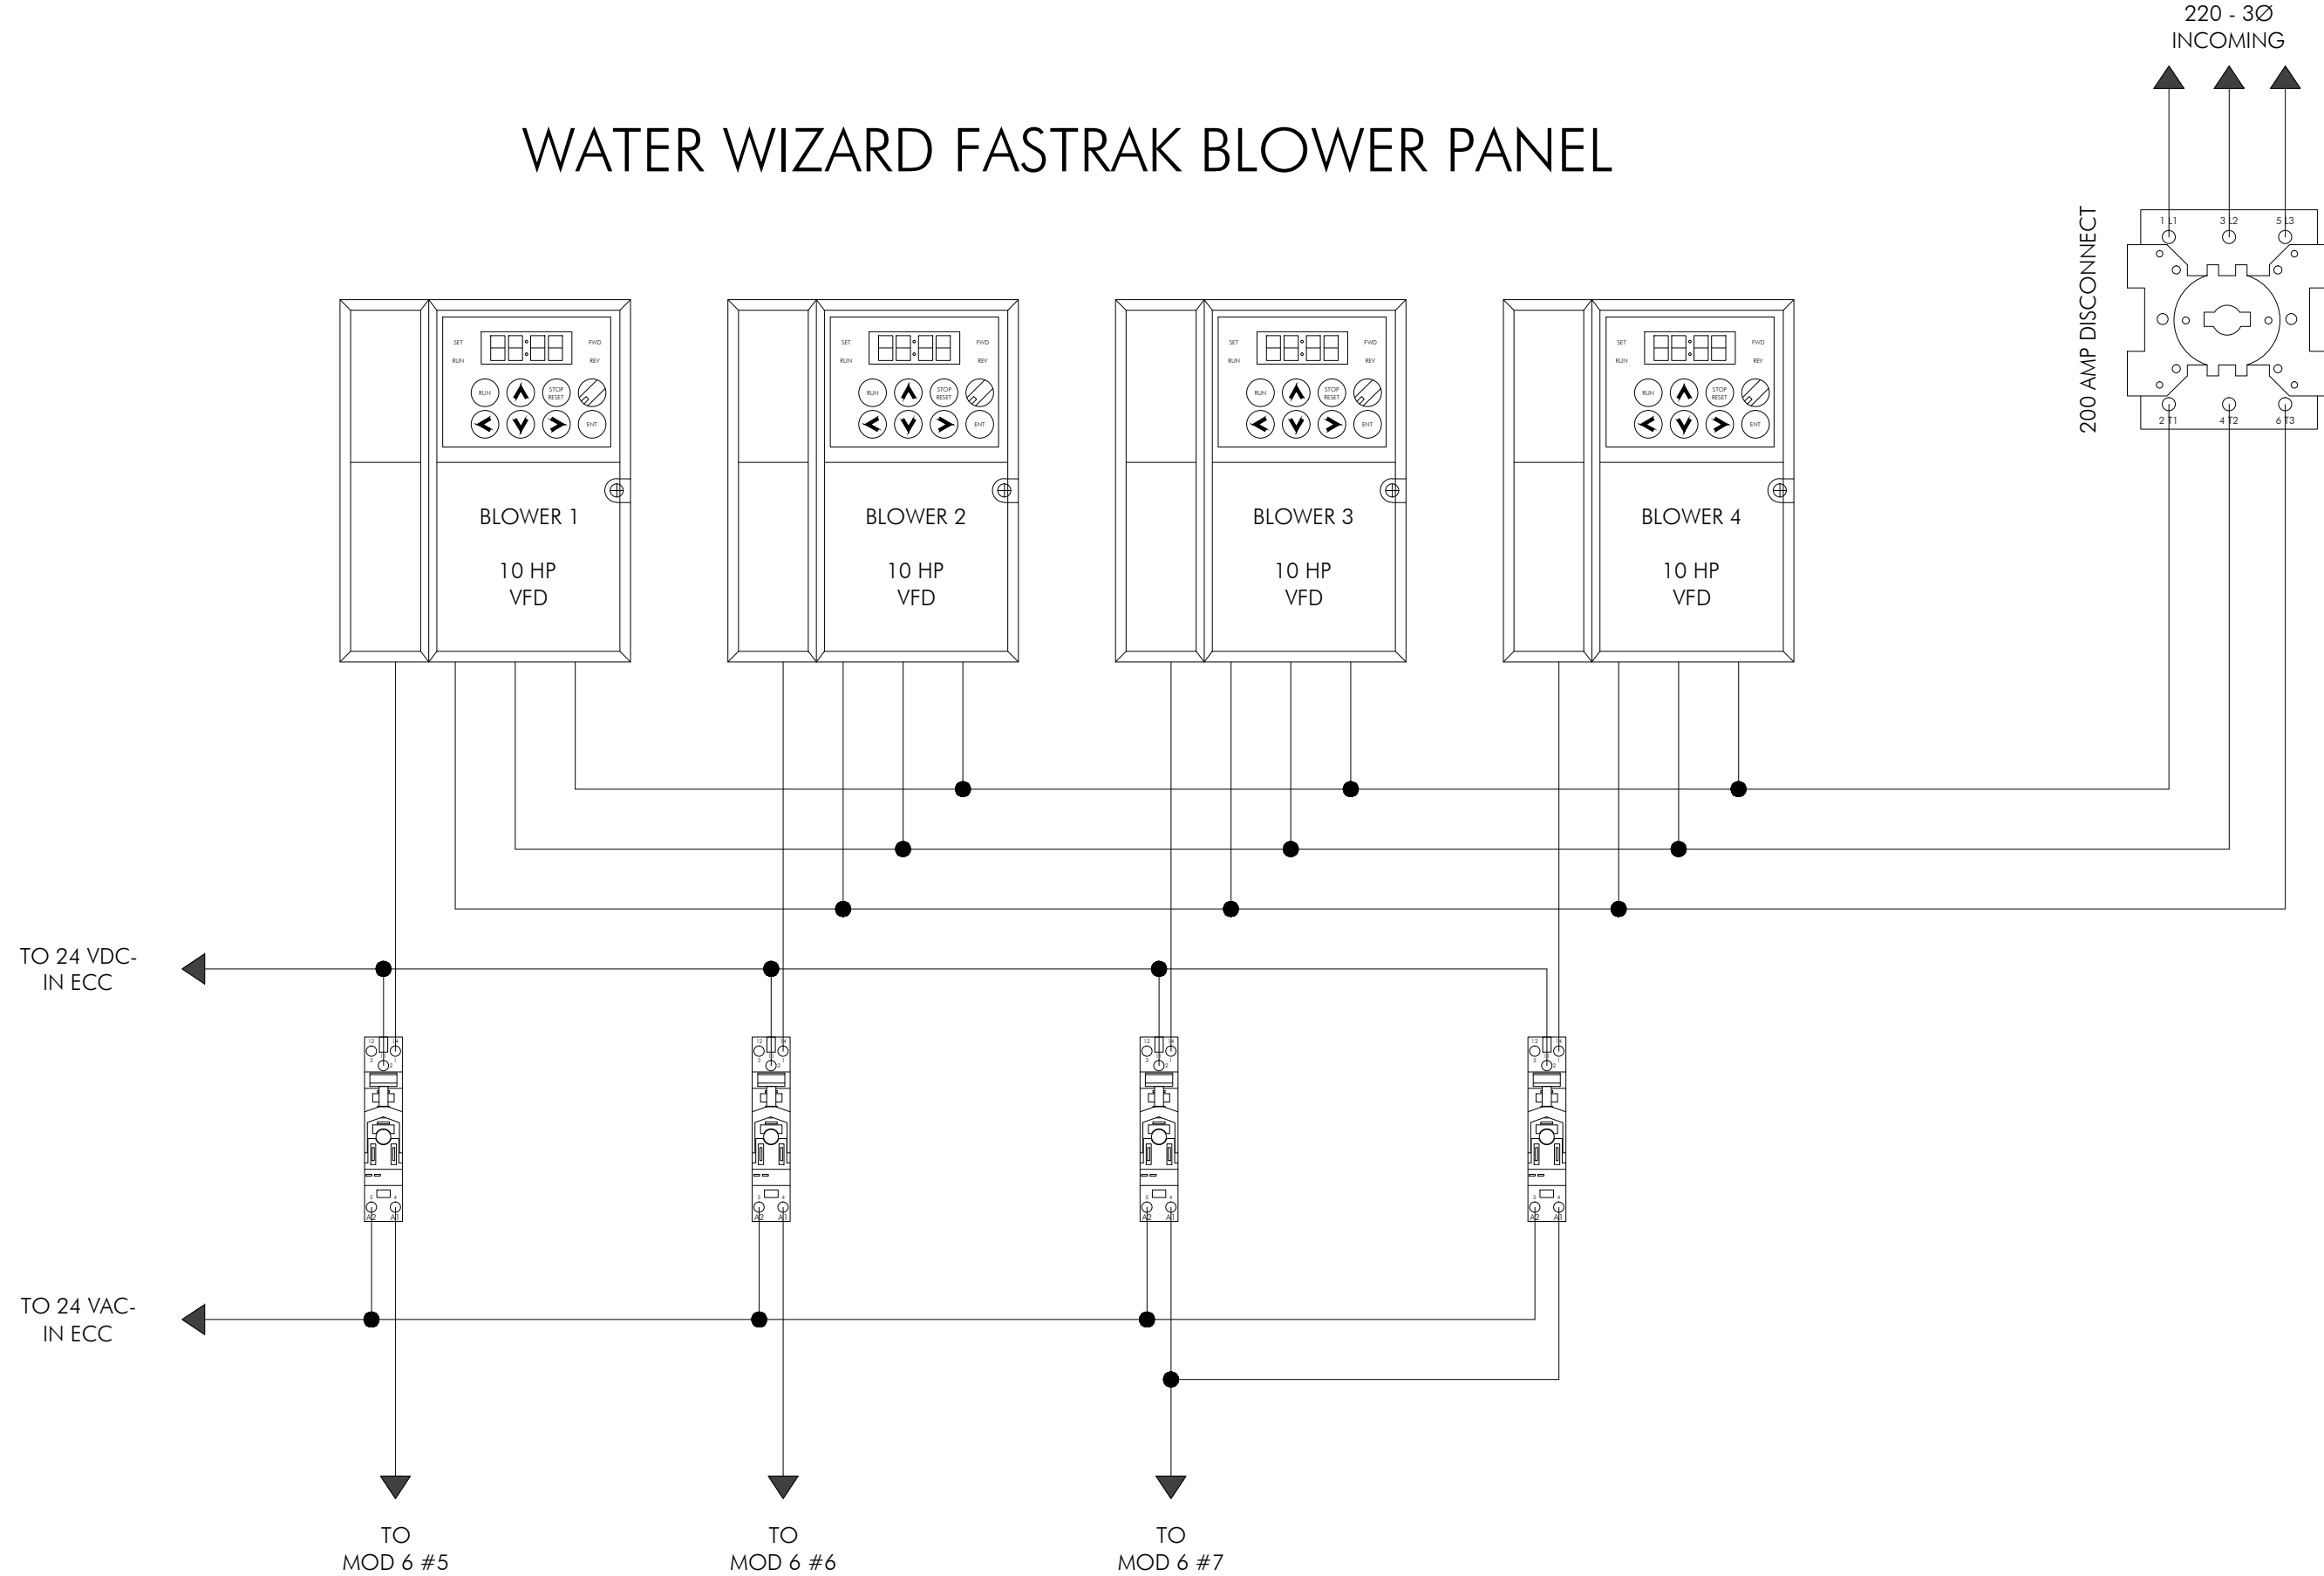


SHEET:	OWNER: COLEMAN HANNA CAR WASH SYSTEMS, LLC 5842 WEST 34TH STREET HOUSTON, TX 77092			
	SHEET NAME: FASTRAK (MECHANICAL LAYOUT)			
	SCALE: AS SHOWN	DATE: 04/09/2014	DRAWN BY: JTRVINO	APPROVED BY:
	DRAWING A.K.O.:	EQUIPMENT A.K.O.:	FILE NAME: T:\W-FASTRAK\FT1.0.dwg	
 <p>AN O'HANRAHAN COLEMAN COMPANY</p> <p>5842 WEST 34TH STREET HOUSTON, TEXAS 77092 PH: 1-800-999-8078 FAX: 713-659-8624 www.colemanhanna.com</p>				
ENGINEER SEAL OR APPROVAL:				
ERISONS				
FT1.0				

# WATER WIZARD FASTRAK BLOWER PANEL




OWNER: COLEMAN HANNA CAR WASH SYSTEMS, LLC 5842 WEST 34TH STREET HOUSTON, TX 77092		APPROVED BY: R. COLEMAN	
SHEET NAME: WATER WIZARD FASTRACK BLOWER PANEL		DRAWN BY: J.TREVINO	
SCALE: AS SHOWN	DATE: 12/08/2014	EQUIPMENT ACO: T1:BLOCKS/ELECTRICAL/FASTRACK/FT.BP.DWG	
DRAWING ACO:		FILE NAME:	

REVISIONS	

ENGINEER SEAL OR APPROVAL:

SHEET:  
**FT.BP**

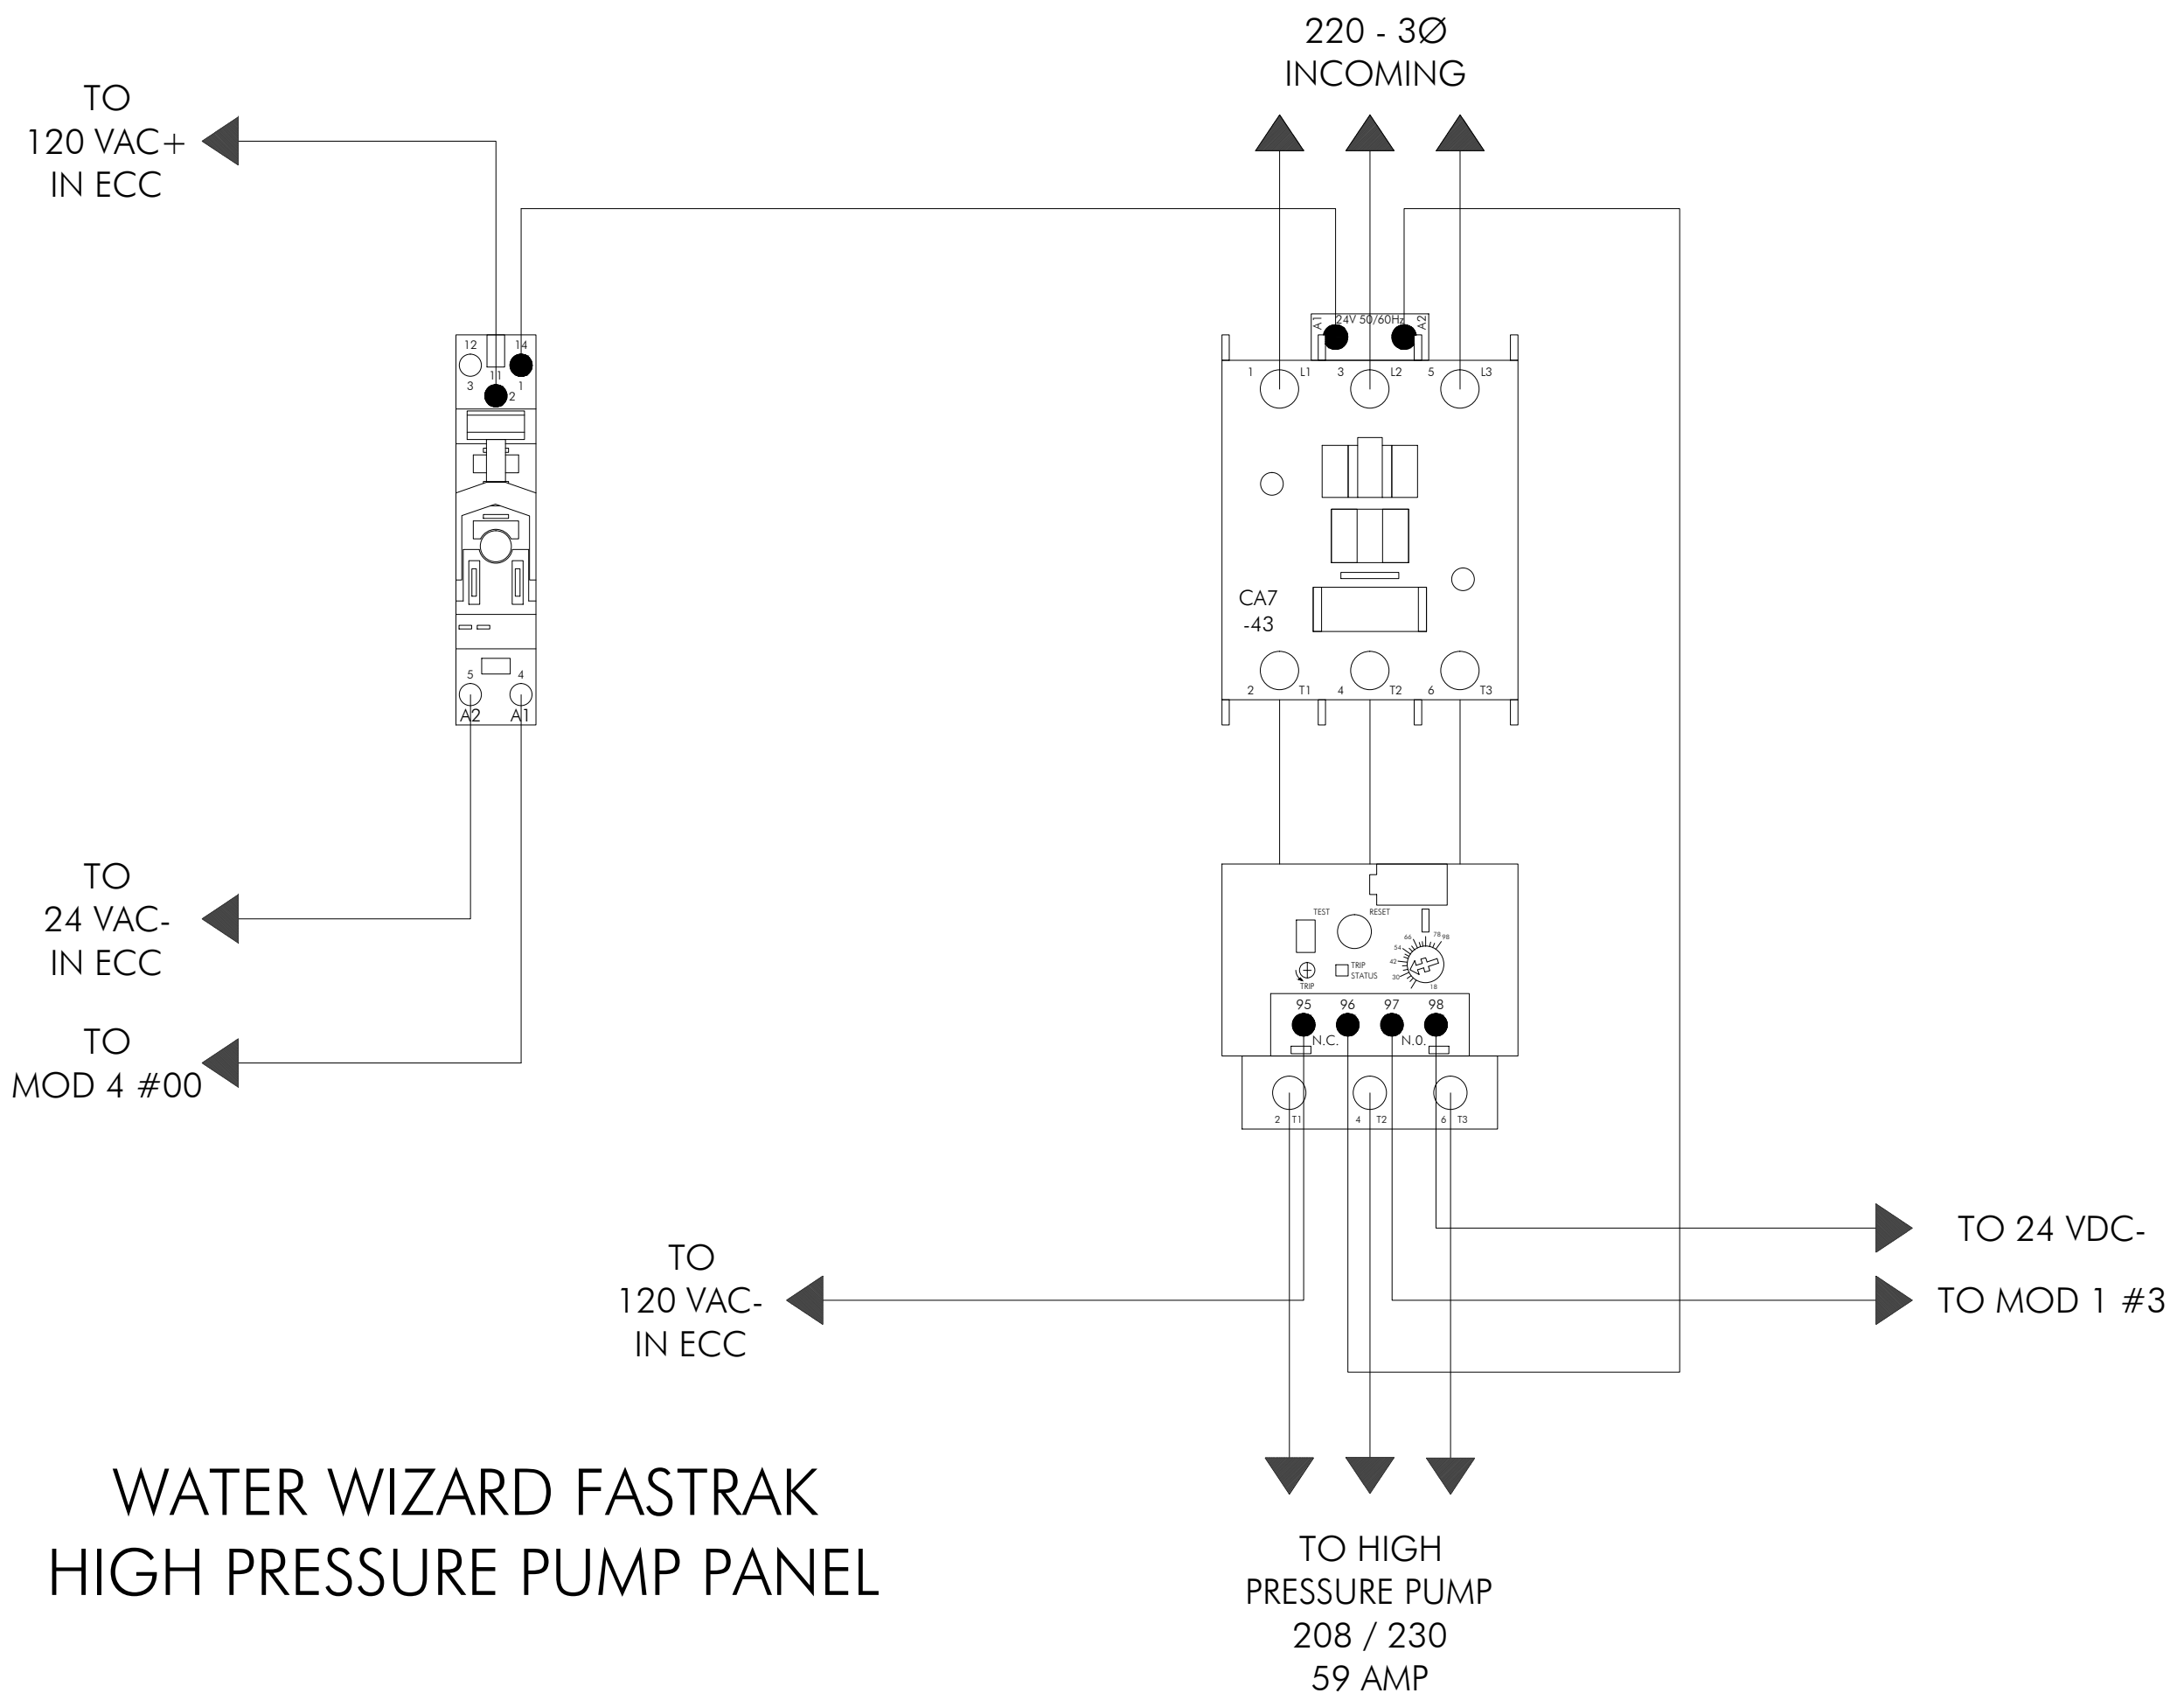

# WATER WIZARD FASTRAK HIGH PRESSURE PUMP PANEL




AN O'HANRAHAN COLEMAN COMPANY  
5842 WEST 34th STREET  
HOUSTON, TEXAS 77092  
PH: 832-9874  
WWW.COLEMANHANNA.COM

OWNER: COLEMAN HANNA CAR WASH SYSTEMS, LLC 5842 WEST 34TH STREET HOUSTON, TX 77092		APPROVED BY: R. COLEMAN	
SHEET NAME: WATER WIZARD FASTRAK HIGH PRESSURE PUMP PANEL		DRAWN BY: J.TREVINO	
SCALE: AS SHOWN	DATE: 12/08/2014	EQUIPMENT A/C: .	
DRAWING A/C: .	FILE NAME: T:\BIDDING\ELECTRICAL\FASTRACK\FT_HP.DWG		

REVISIONS	

ENGINEER SEAL OR APPROVAL:


SHEET:  
**FT.HP**

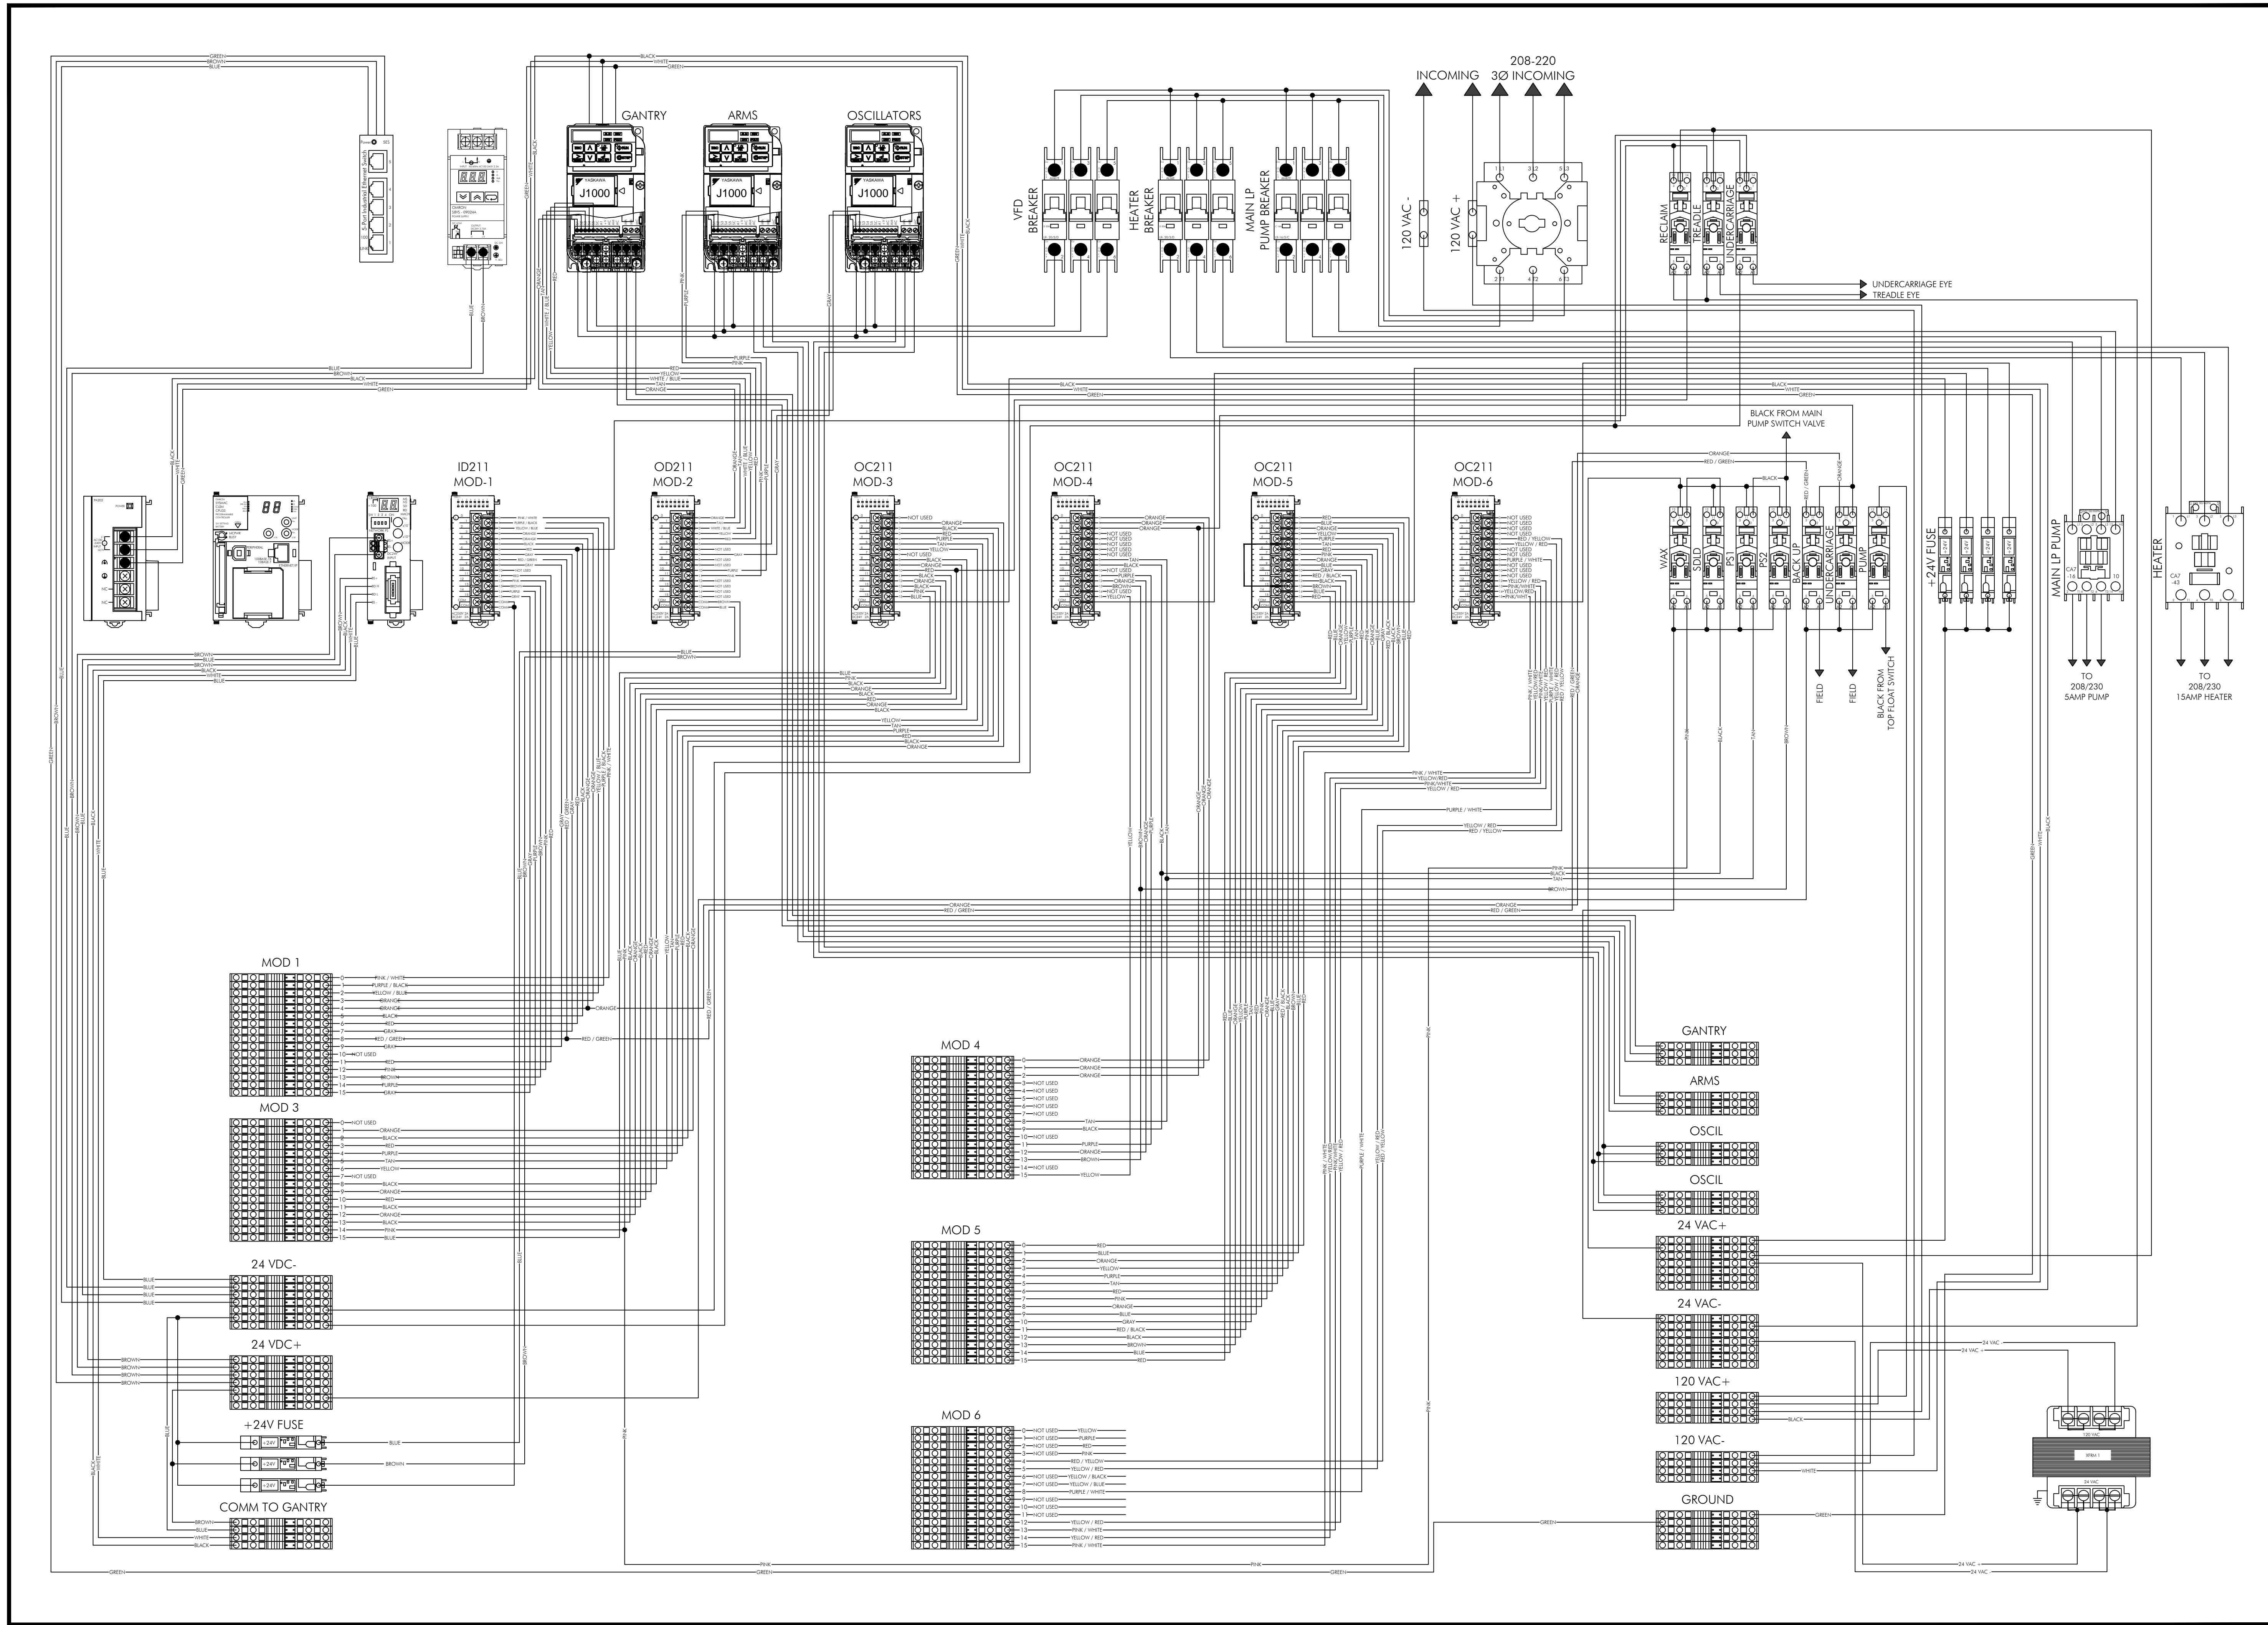


REVISIONS

NO.	DESCRIPTION

ENGINEER SEAL OR APPROVAL:

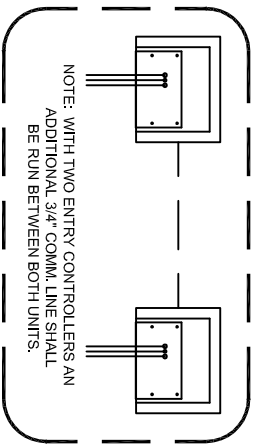

NOTE:  
CONFIRM TREADLE  
CONFIGURATION WITH OWNER

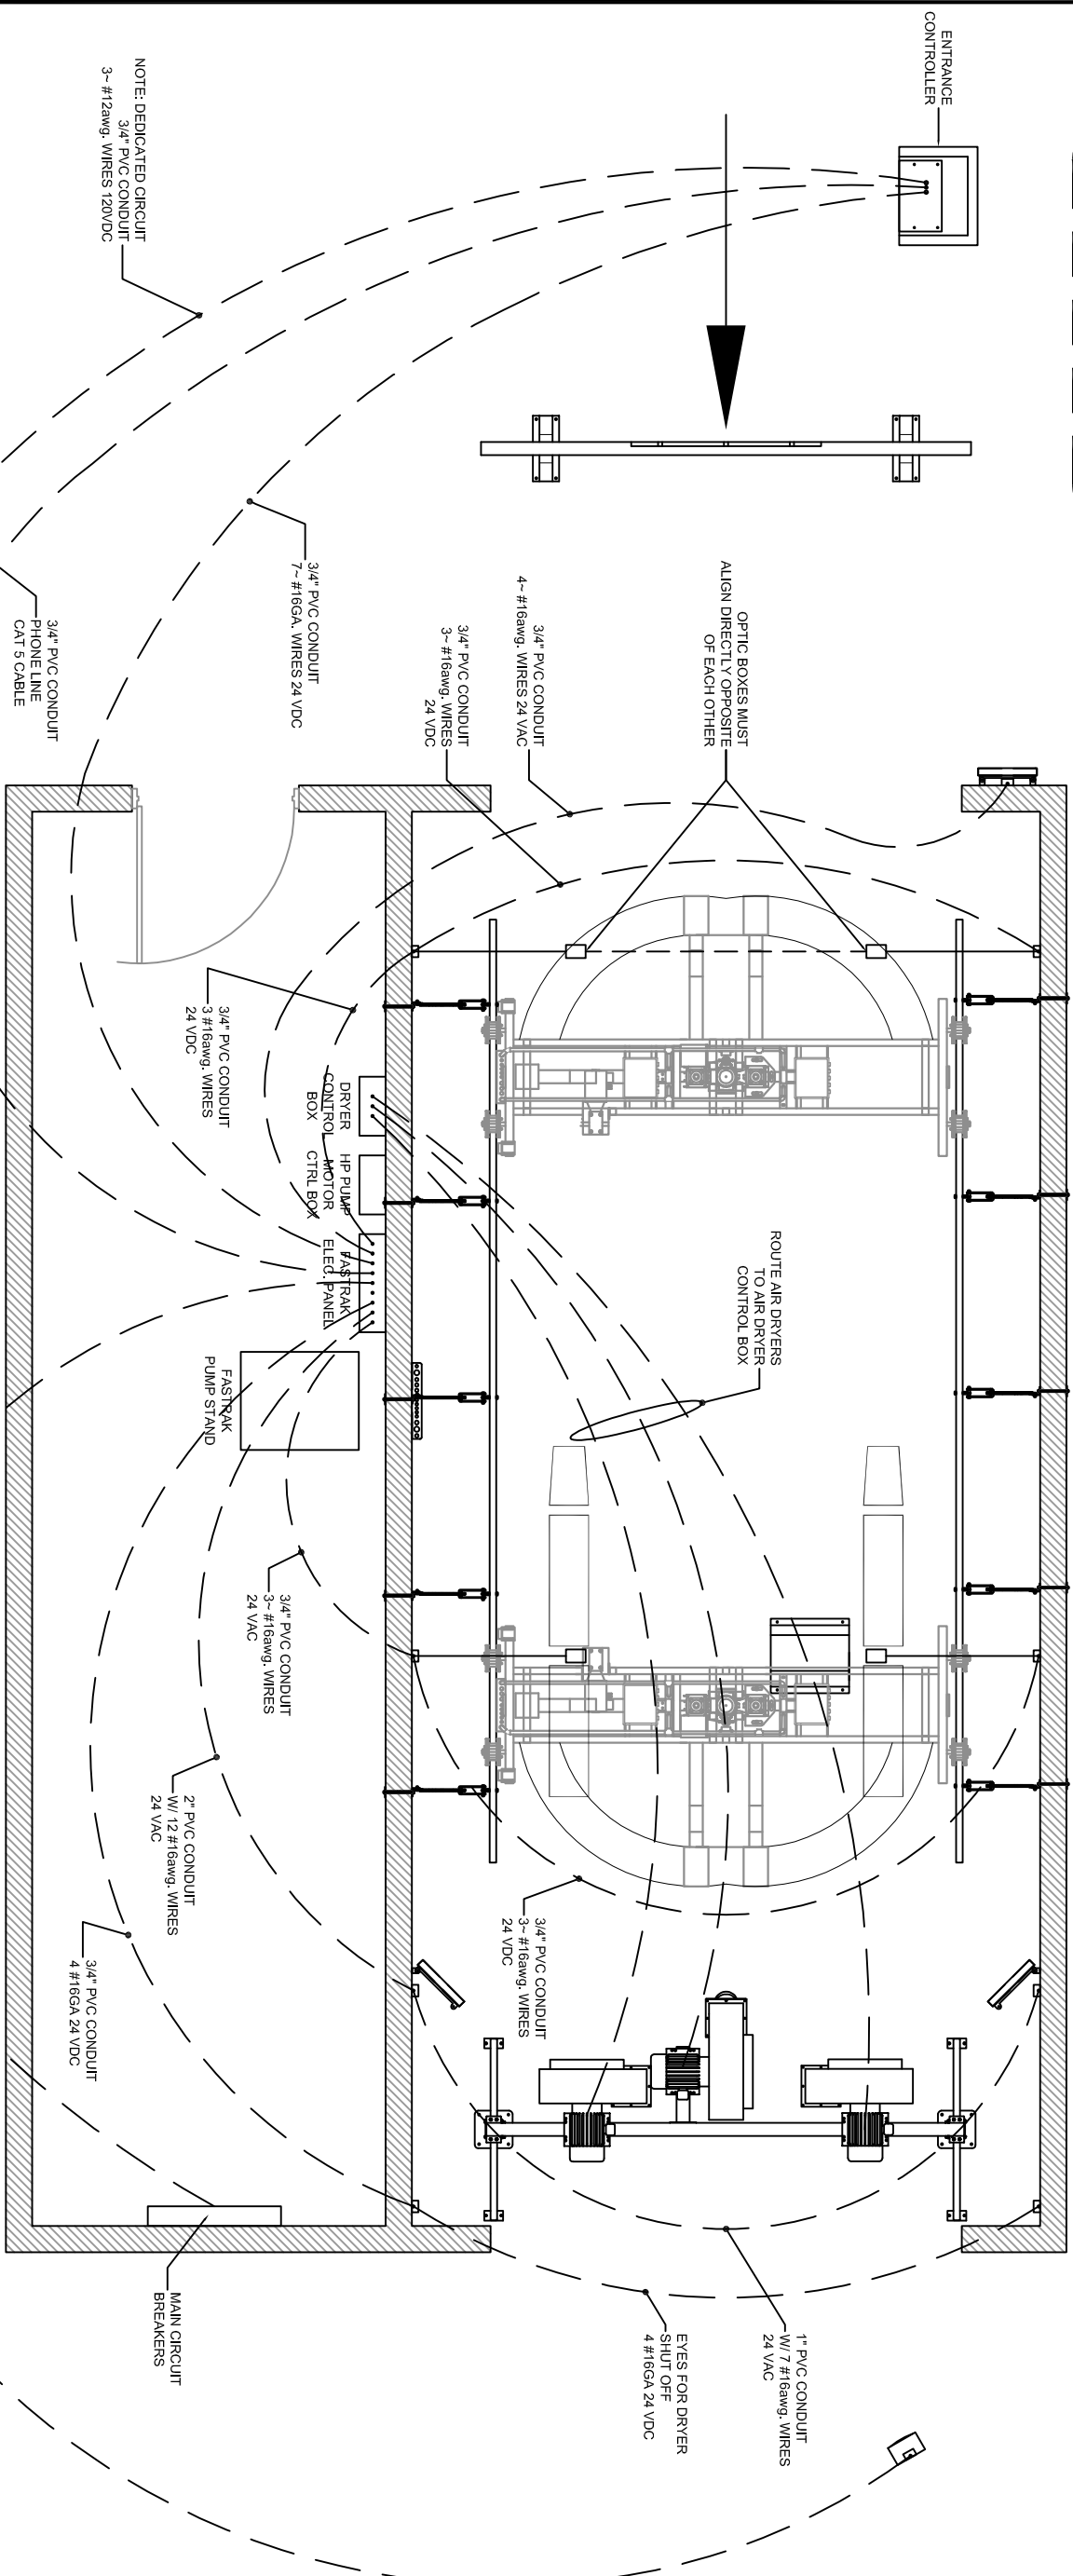


**ELECTRICAL NOTES:**

- (1) **FASTRAK MAIN CONTROL BOX**  
60 AMP 3 PHASE BREAKER  
+ NEUTRAL + GROUND
- (2) **HIGH PRESSURE PUMP MOTOR CONTROL BOX**  
REQUIRES 100 AMP BREAKER  
3 PHASE 208 / VOLT
- (3) **AIR DRYER CONTROL BOX**  
3-CIRCUITS 60 AMP BREAKERS 208 V 3 PHASE  
FROM ELECTRICAL PANEL  
1 - CIRCUIT FOR ALL 3 MOTORS (OPTIONAL)

\*\*\* ELECTRICIAN TO VERIFY WITH OWNER \*\*\*

**FASTRAK W/ 24' TRACK RAIL**

CONFIRM EQUIPMENT  
ORDER WITH OWNER

REVISIONS    ENGINEER SEAL OR APPROVAL:	OWNER: COLEMAN HANNA CAR WASH SYSTEMS, LLC 5842 WEST 34TH STREET HOUSTON, TX 77092			
	SHEET NAME: FASTRAK ELECTRICAL CONDUIT RUNS			
	SCALE: AS SHOWN	DATE: 06/04/2014	DRAWN BY: JTREVINO	APPROVED BY:
	DRAWING A.K.O.:	EQUIPMENT A.K.O.:	FILE NAME: T:\W-FASTRAK\FT3.0.dwg	
 AN O'HANRAHAN COLEMAN COMPANY <small>5842 WEST 34TH STREET HOUSTON, TEXAS 77092 PH: 800-999-9878 FAX: 713-225-8876 www.colemanhanna.com</small>				
SHEET: FT3.0				