


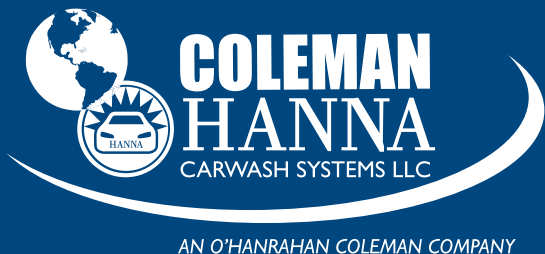

FasTrak Technical Drawings




5842 W 34th St • Houston, TX 77092
1.800.999.9878 • 1.713.683.9878

www.colemanhanna.com



Find us on Facebook:
[/ColemanHannaCarwash](https://www.facebook.com/ColemanHannaCarwash)

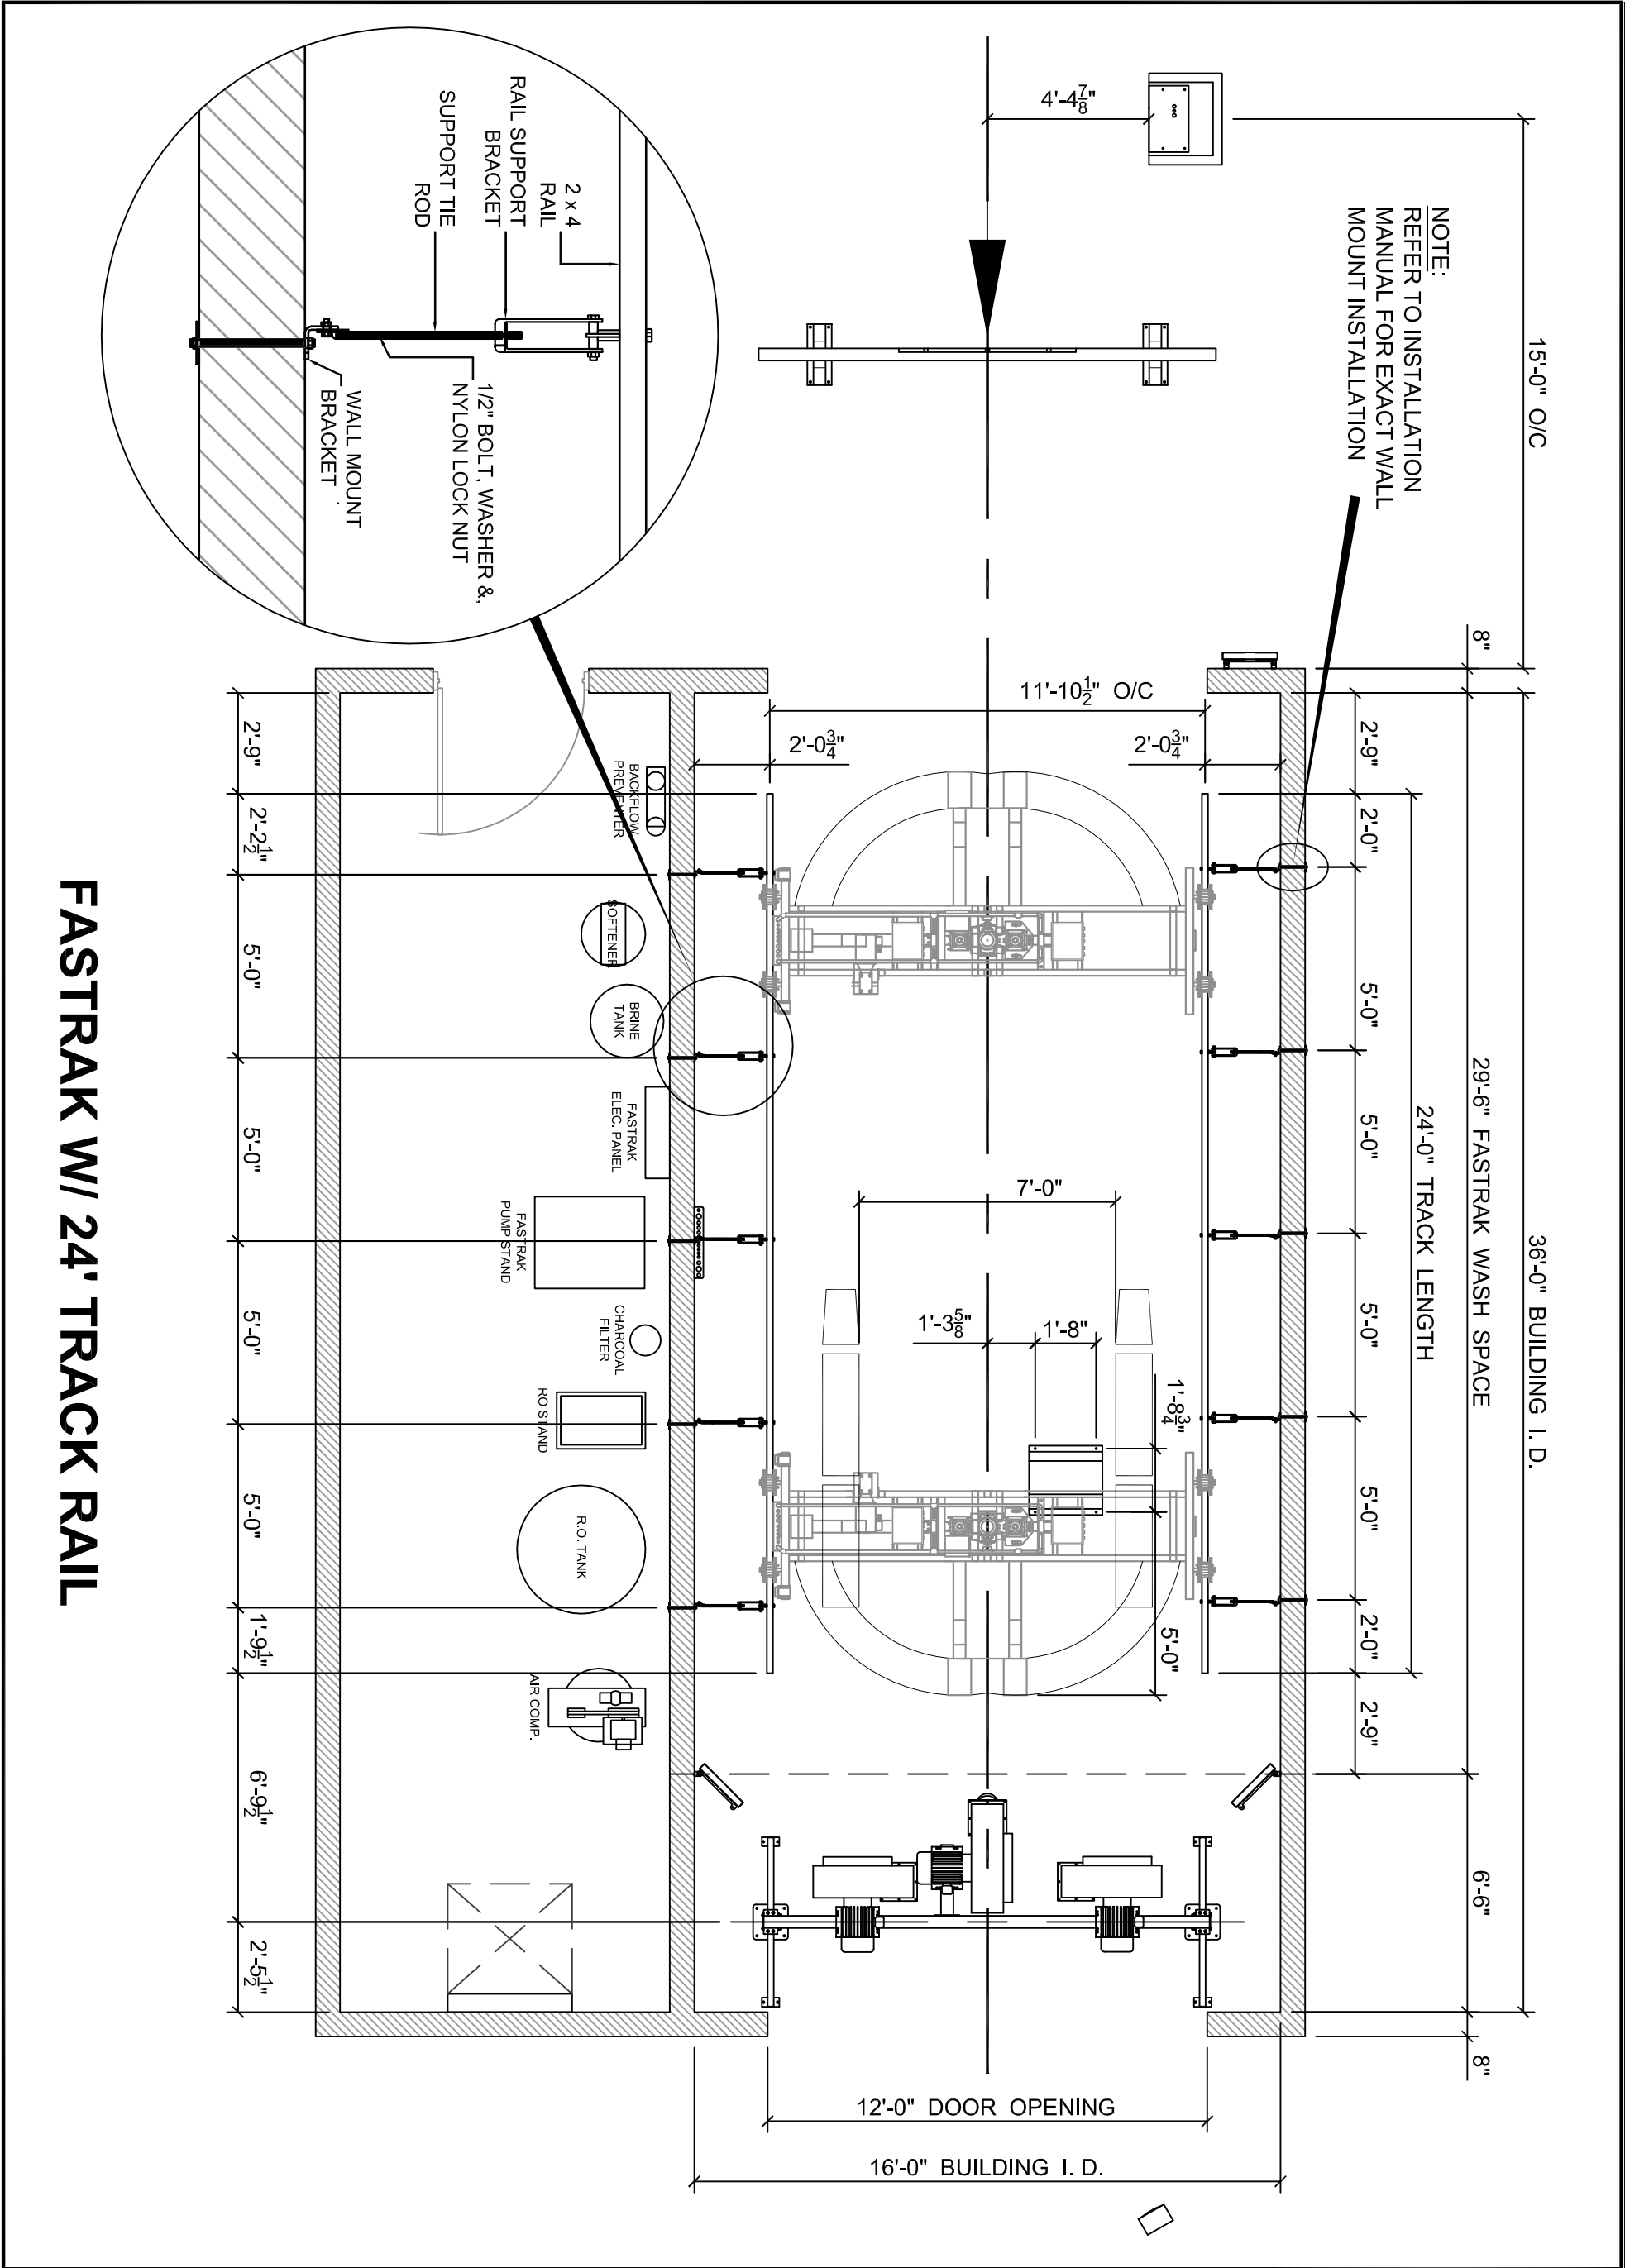

FASTRAK W/ 24' TRACK RAIL


SHEET: FT1.0	OWNER: COLEMAN HANNA CAR WASH SYSTEMS, LLC 5842 WEST 34TH STREET HOUSTON, TX 77092			
	SHEET NAME: FASTRAK (MECHANICAL LAYOUT)			
	SCALE: AS SHOWN	DATE: 04/09/2014	DRAWN BY: JREVINO	APPROVED BY:
	DRAWING A.K.O.:	EQUIPMENT A.K.O.:	FILE NAME: T:\W-FASTRAK\FT1.0.dwg	TITLE:
ERISONS				
ENGINEER SEAL OR APPROVAL:				

COLEMAN HANNA
CARWASH SYSTEMS LLC

AN O'HANRAHAN COLEMAN COMPANY

5842 WEST 34TH STREET
HOUSTON, TEXAS 77092
PH: 1-800-999-8078 FAX: 713-659-8624
www.colemanhanna.com

WATER WIZARD FASTRAK BLOWER PANEL

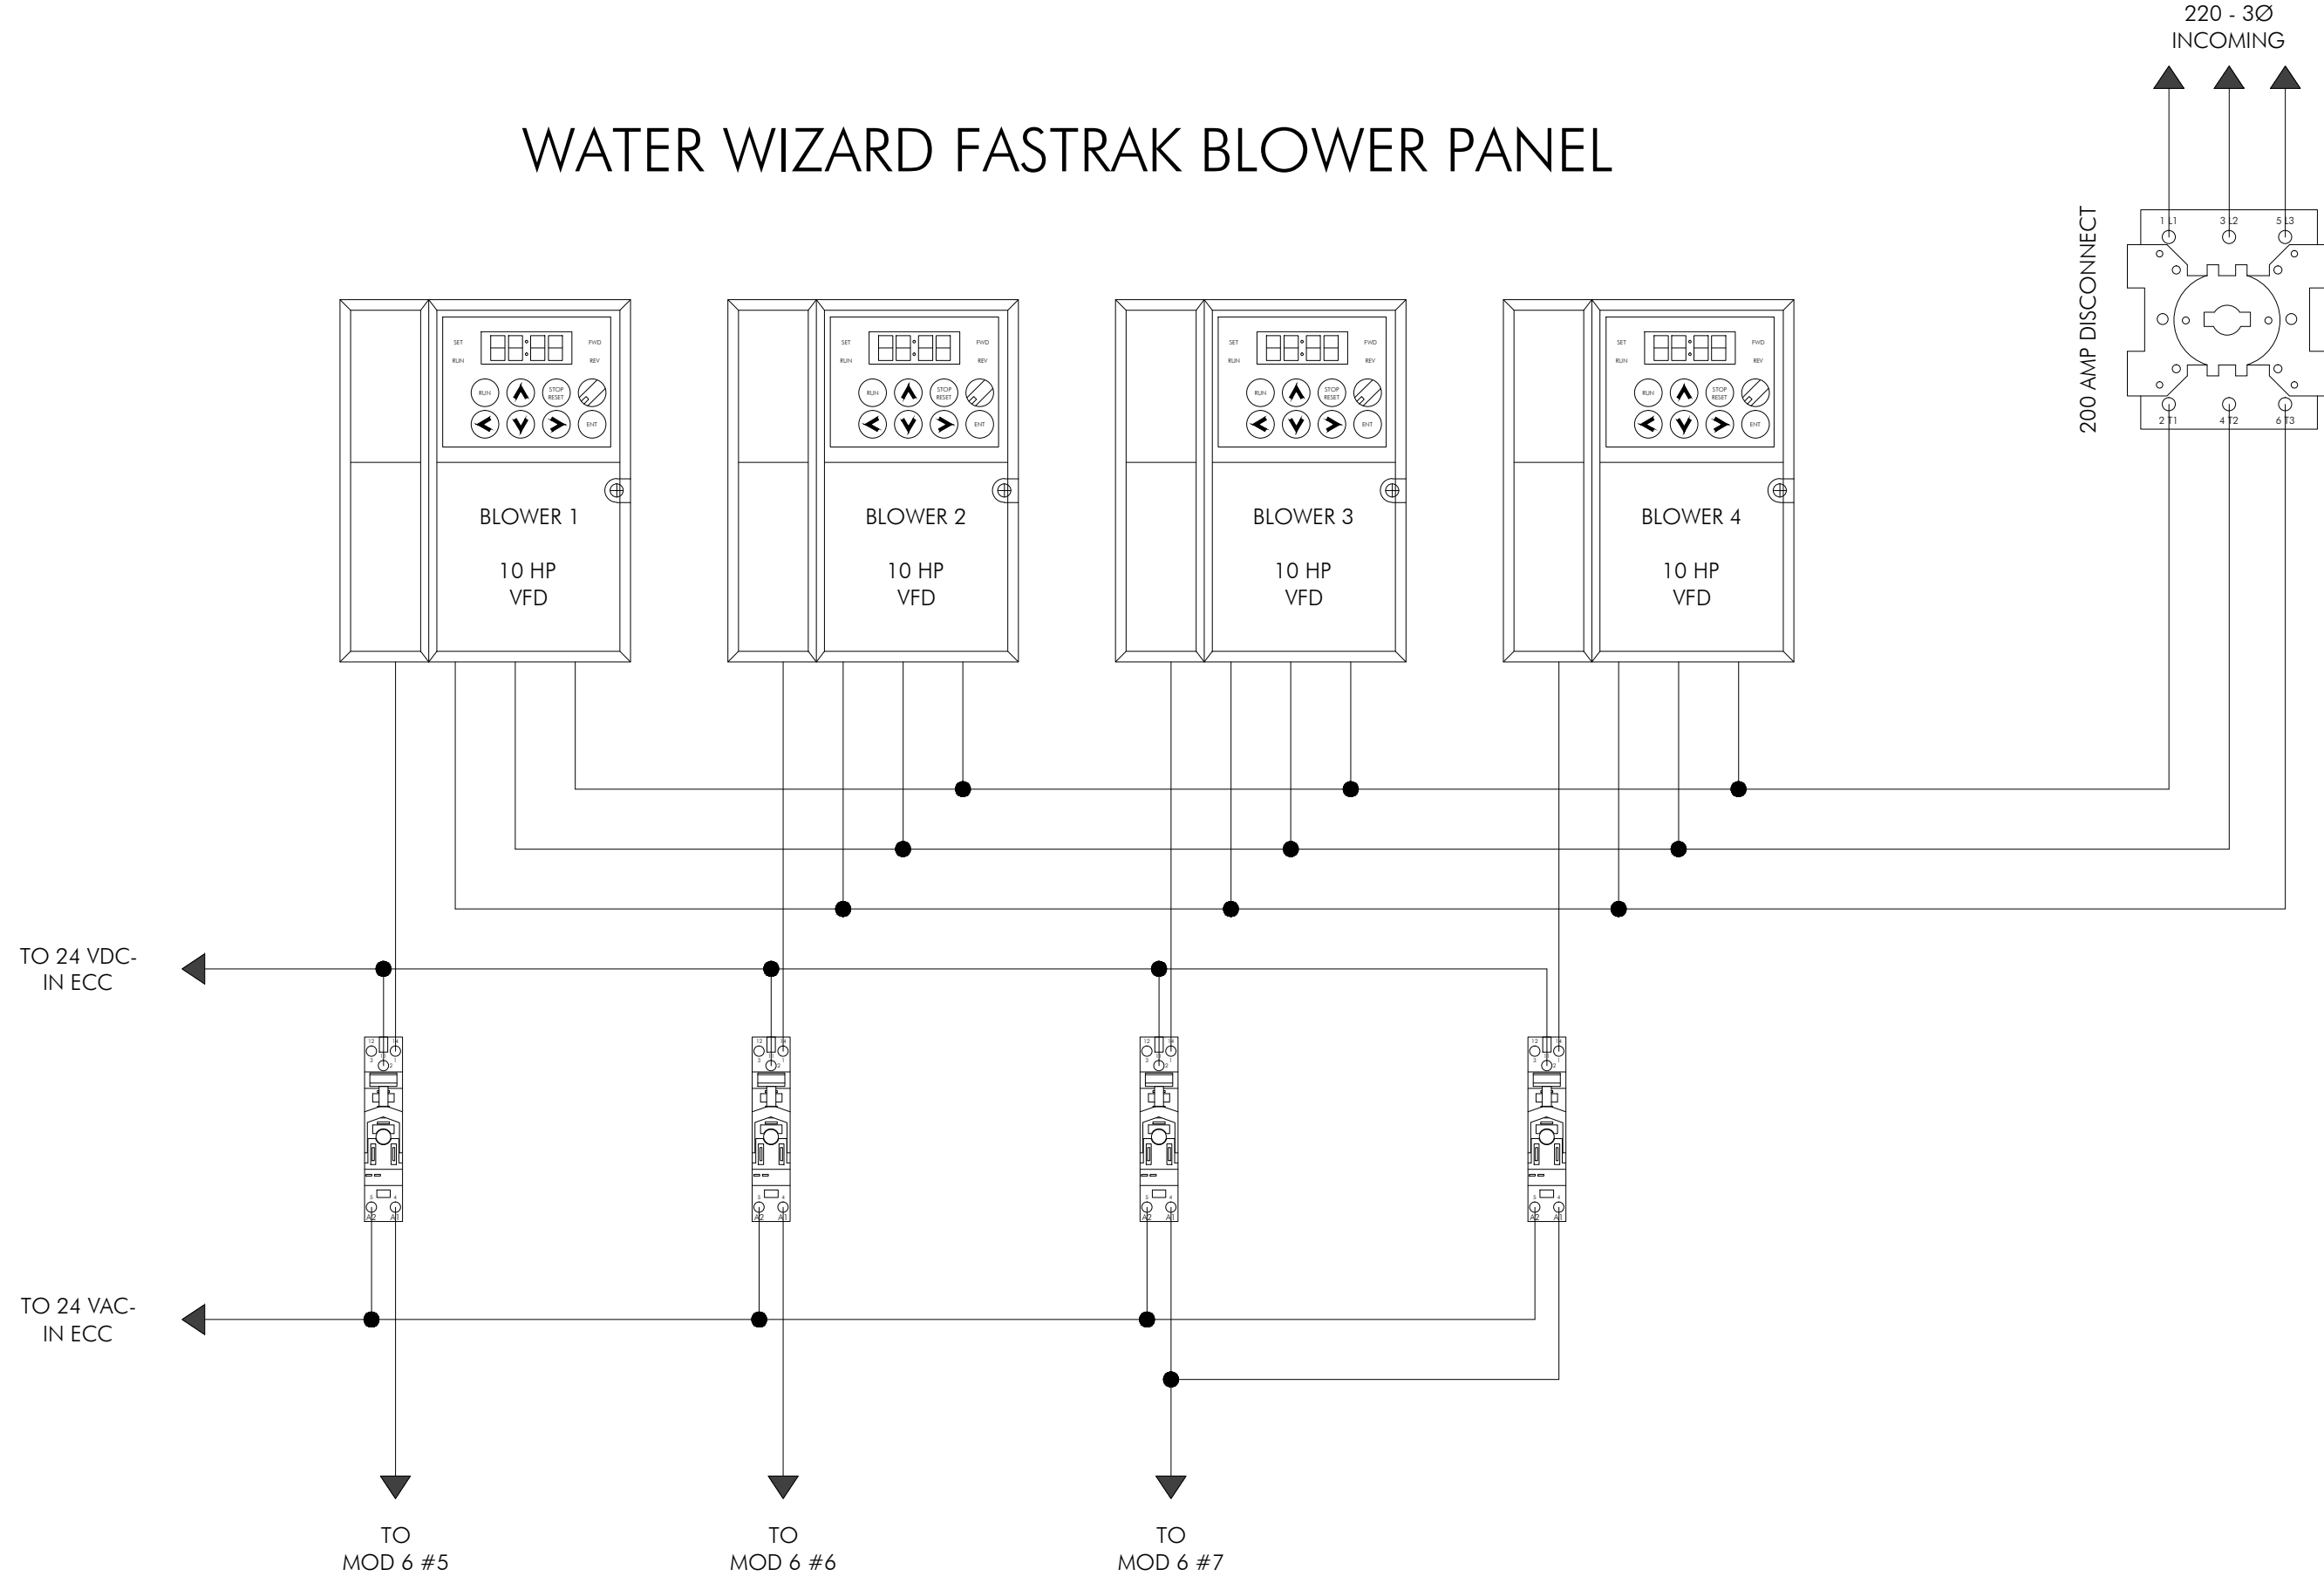


OWNER: COLEMAN HANNA CAR WASH SYSTEMS, LLC 5842 WEST 34TH STREET HOUSTON, TX 77092		APPROVED BY: R. COLEMAN	
SHEET NAME: WATER WIZARD FASTRACK BLOWER PANEL		DRAWN BY: J.TREVINO	
SCALE: AS SHOWN	DATE: 12/08/2014	EQUIPMENT ACO: T1:BLOCKS/ELECTRICAL/FASTRACK/FT.BP.DWG	
DRAWING ACO:		FILE NAME:	

REVISIONS	

ENGINEER SEAL OR APPROVAL:

SHEET:
FT.BP

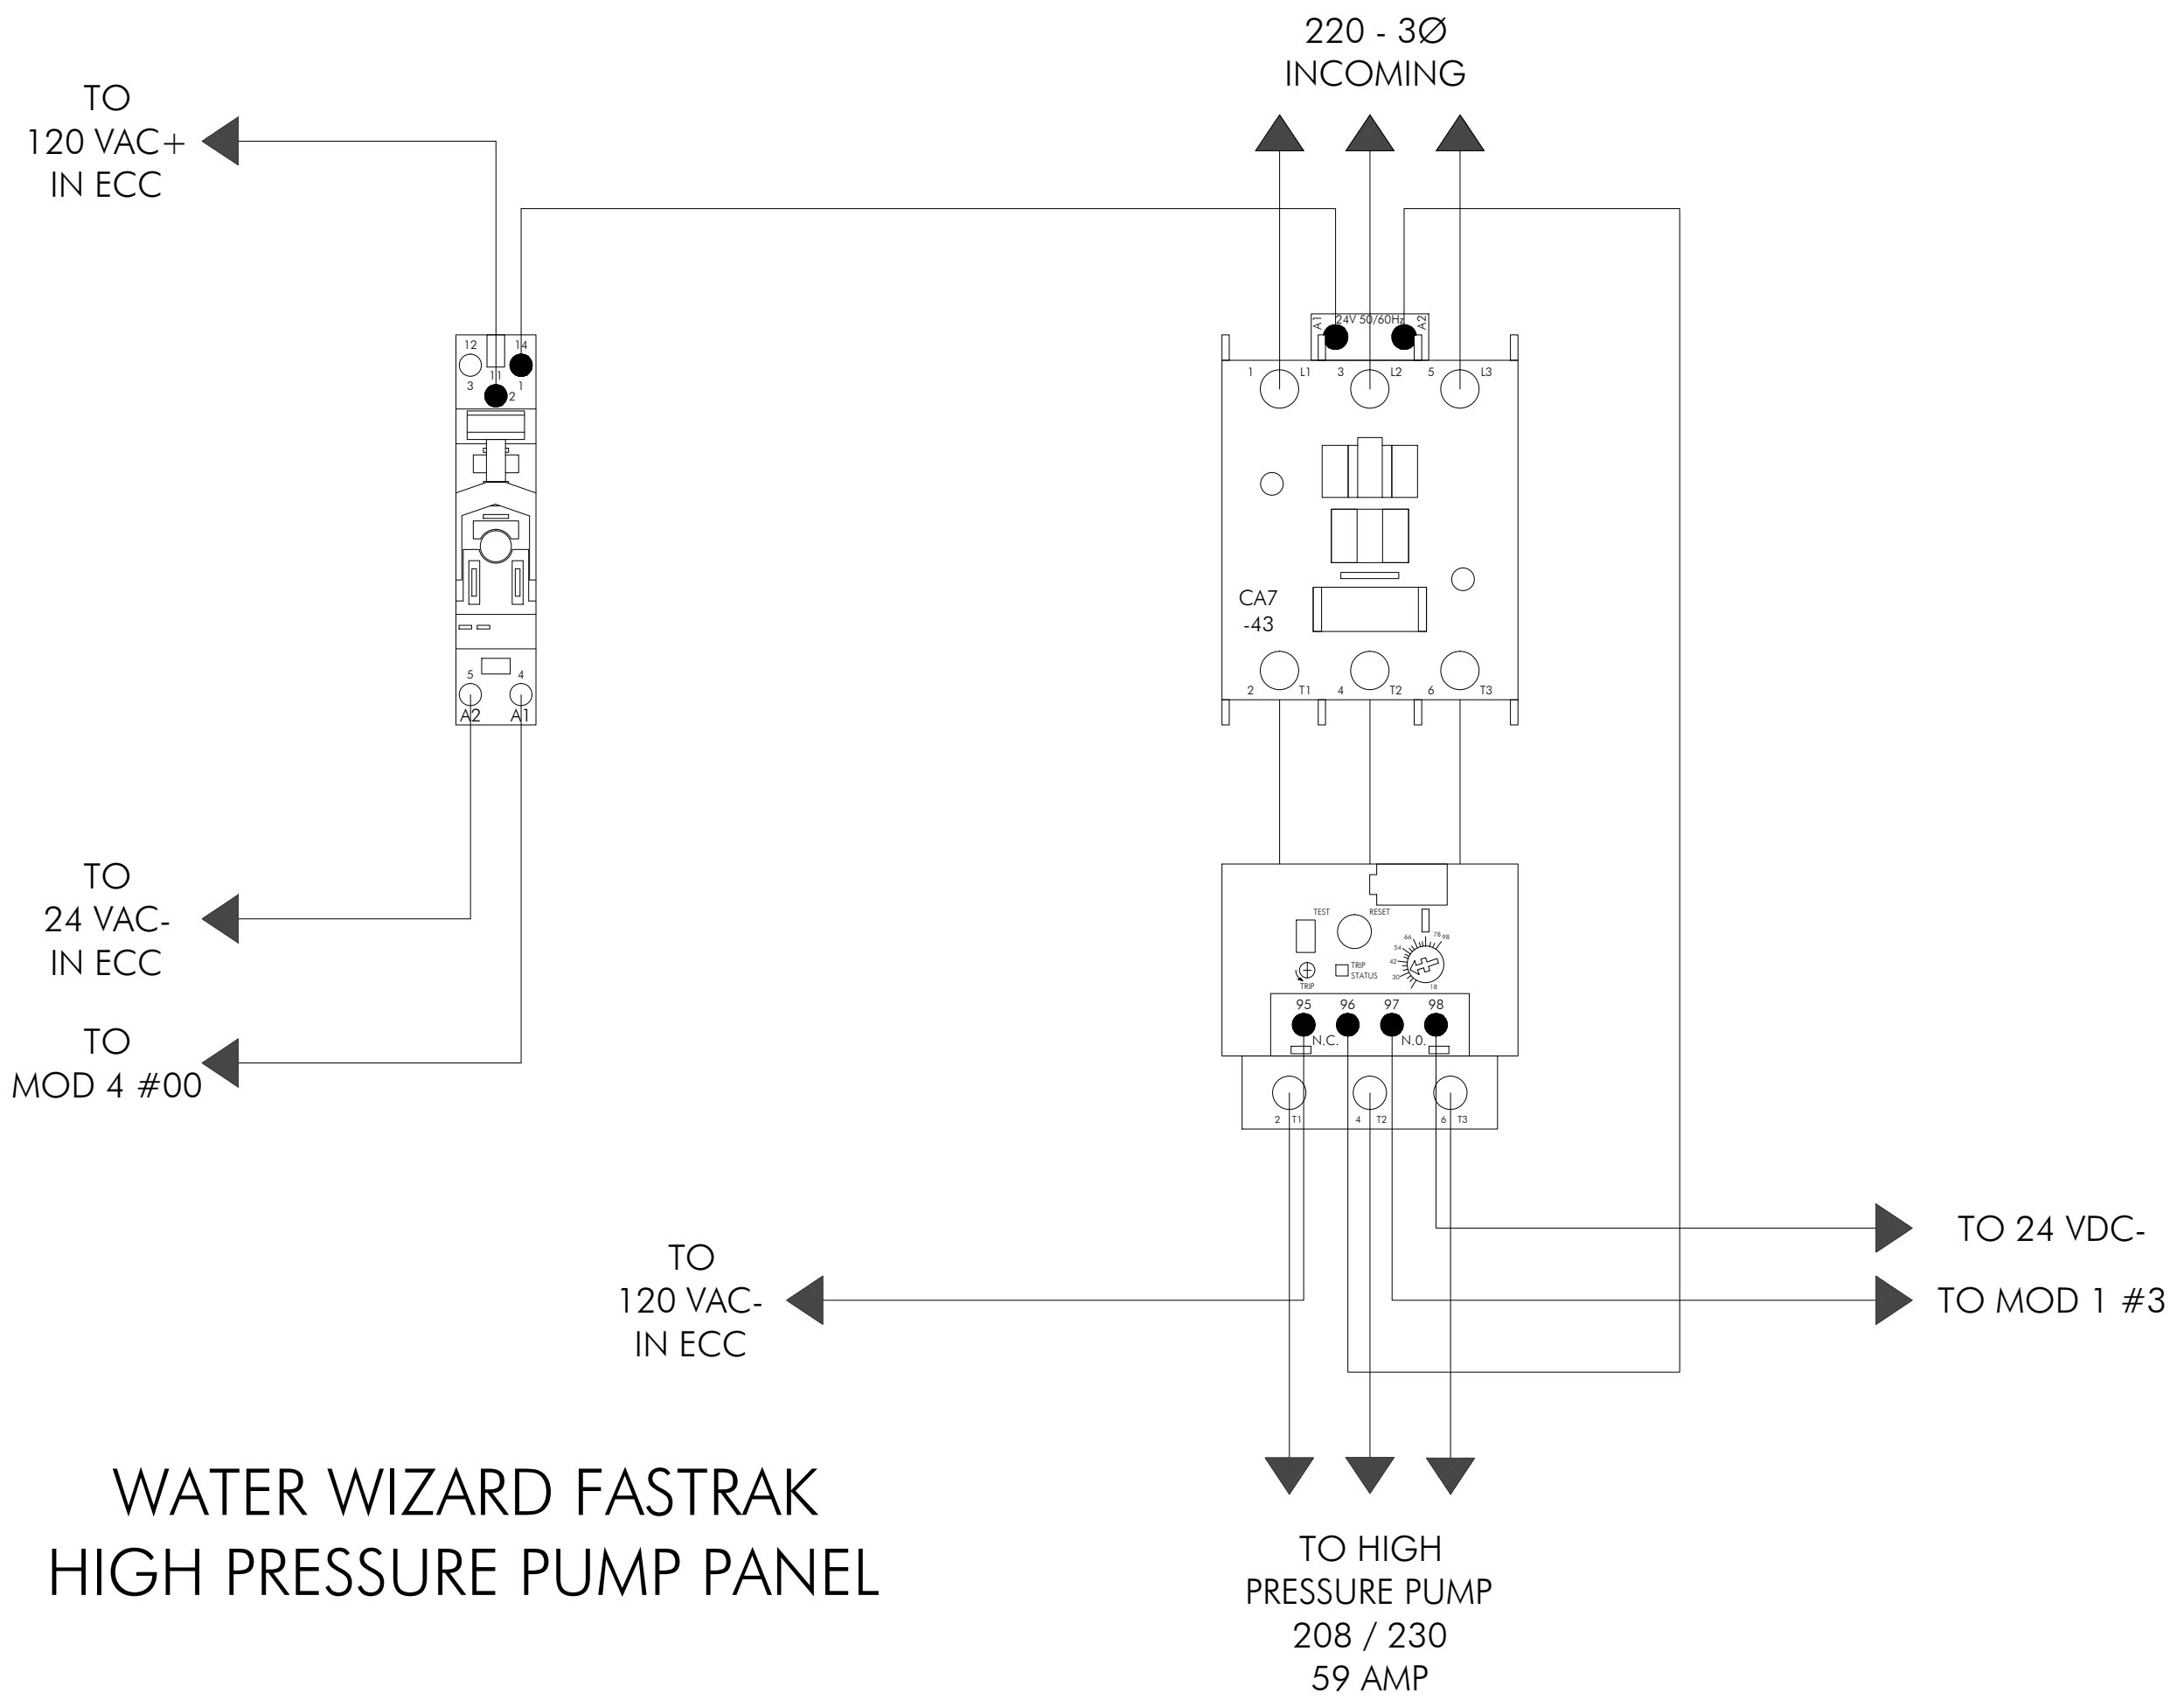


OWNER: COLEMAN HANNA CAR WASH SYSTEMS, LLC 5842 WEST 34TH STREET HOUSTON, TX 77092		APPROVED BY: R. COLEMAN	
SHEET NAME: WATER WIZARD FASTRAK HIGH PRESSURE PUMP PANEL		DRAWN BY: .J.TREVINO	
SCALE: AS SHOWN	DATE: 12/08/2014	EQUIPMENT ACO: .	
DRAWING ACO: .	FILE NAME: T:\BIDDING\ELECTRICAL\FASTRACK\FT_HP.DWG		

REVISIONS	

ENGINEER SEAL OR APPROVAL:

SHEET:
FT.HP

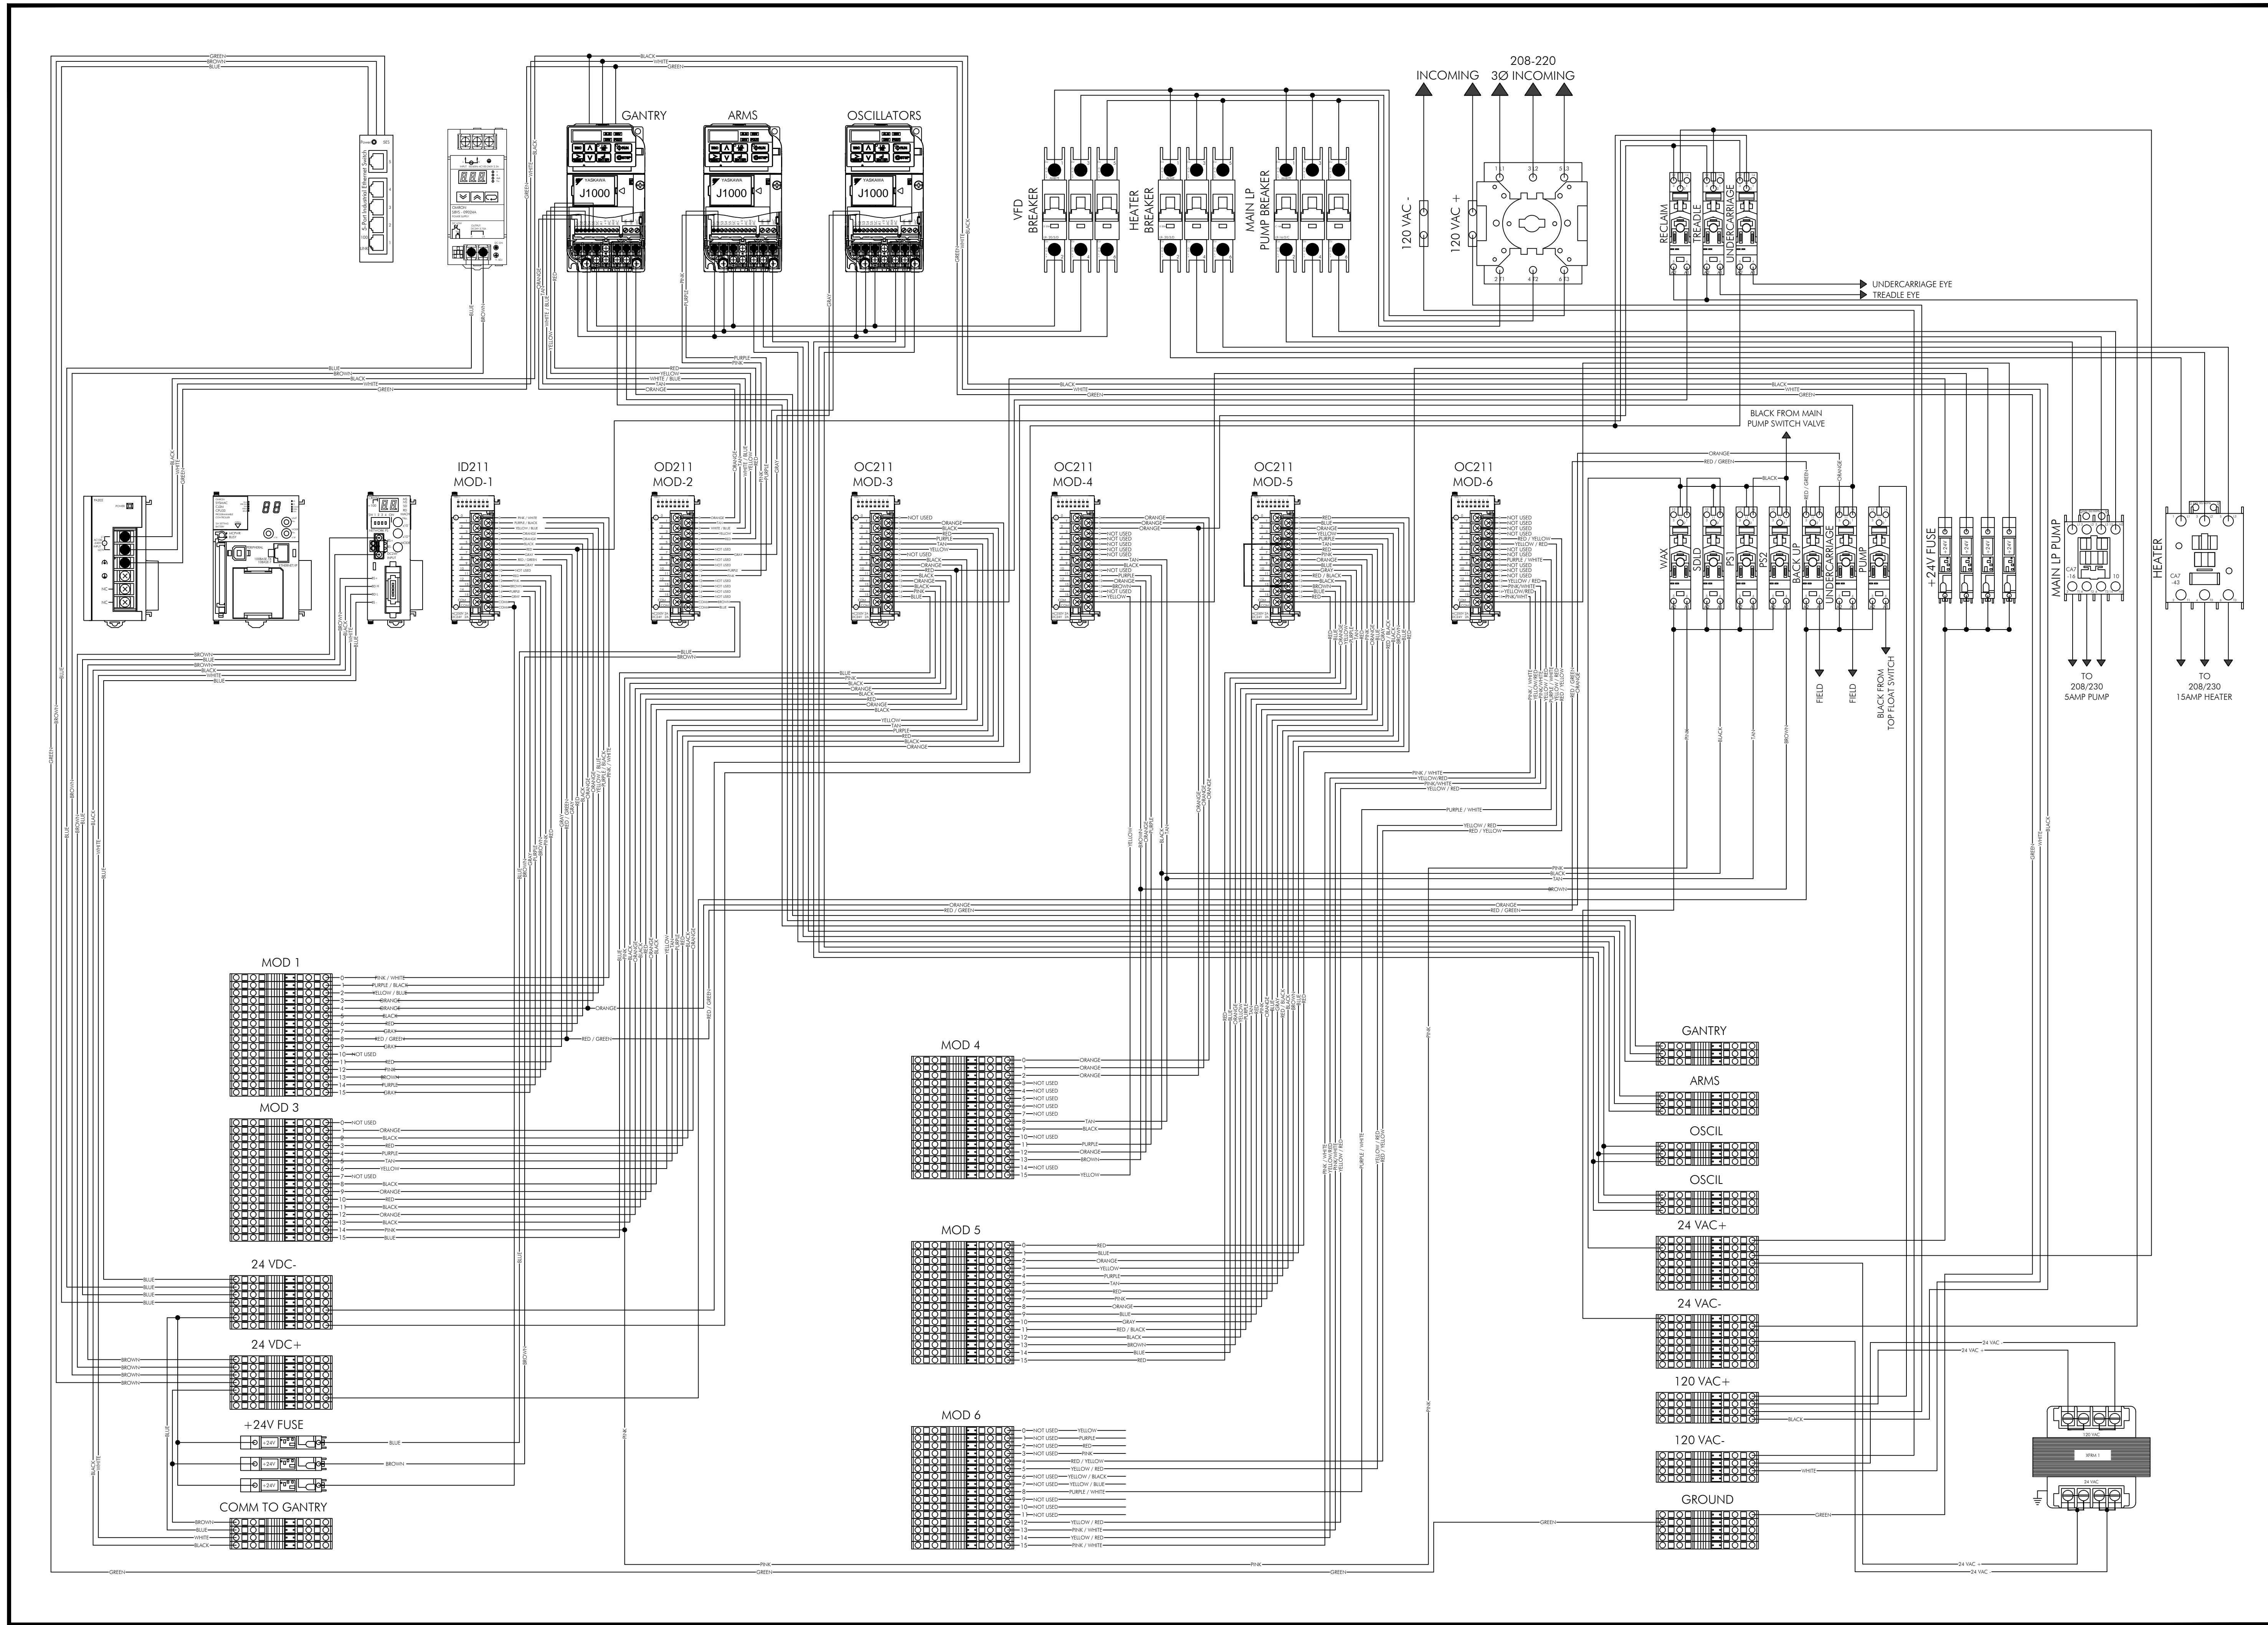

GOLEMAN HANNA
CARWASH SYSTEMS LLC

AN O'HANRAHAN COLEMAN COMPANY

5842 WEST 34TH STREET
HOUSTON, TEXAS 77092
PH: 800.998.9678 FAX: 713.663.9624
www.golemanhanna.com

OWNER: COLEMAN HANNA CAR WASH SYSTEMS, LLC
5842 WEST 34TH STREET
HOUSTON, TX 77092

SHEET NAME: 240/120 WATER WIZARD FASTRACK ELECTRICAL PANEL

DATE: 11/25/2014

DRAWN BY: JIREVINO

APPROVED BY: R. COLEMAN

SCALE: AS SHOWN


EQUIPMENT A.K.O.

FILE NAME: T:\BLOCKS\ELECTRICAL\FASTRACK\FT1.0.DWG


REVISIONS

ENGINEER SEAL OR APPROVAL:

SHEET: FT1.0

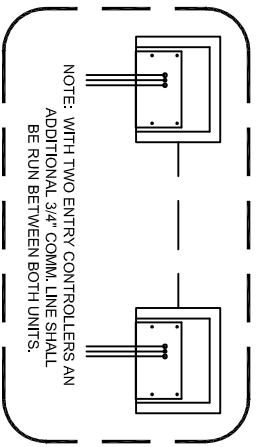

NOTE:
CONFIRM TREADLE
CONFIGURATION WITH OWNER

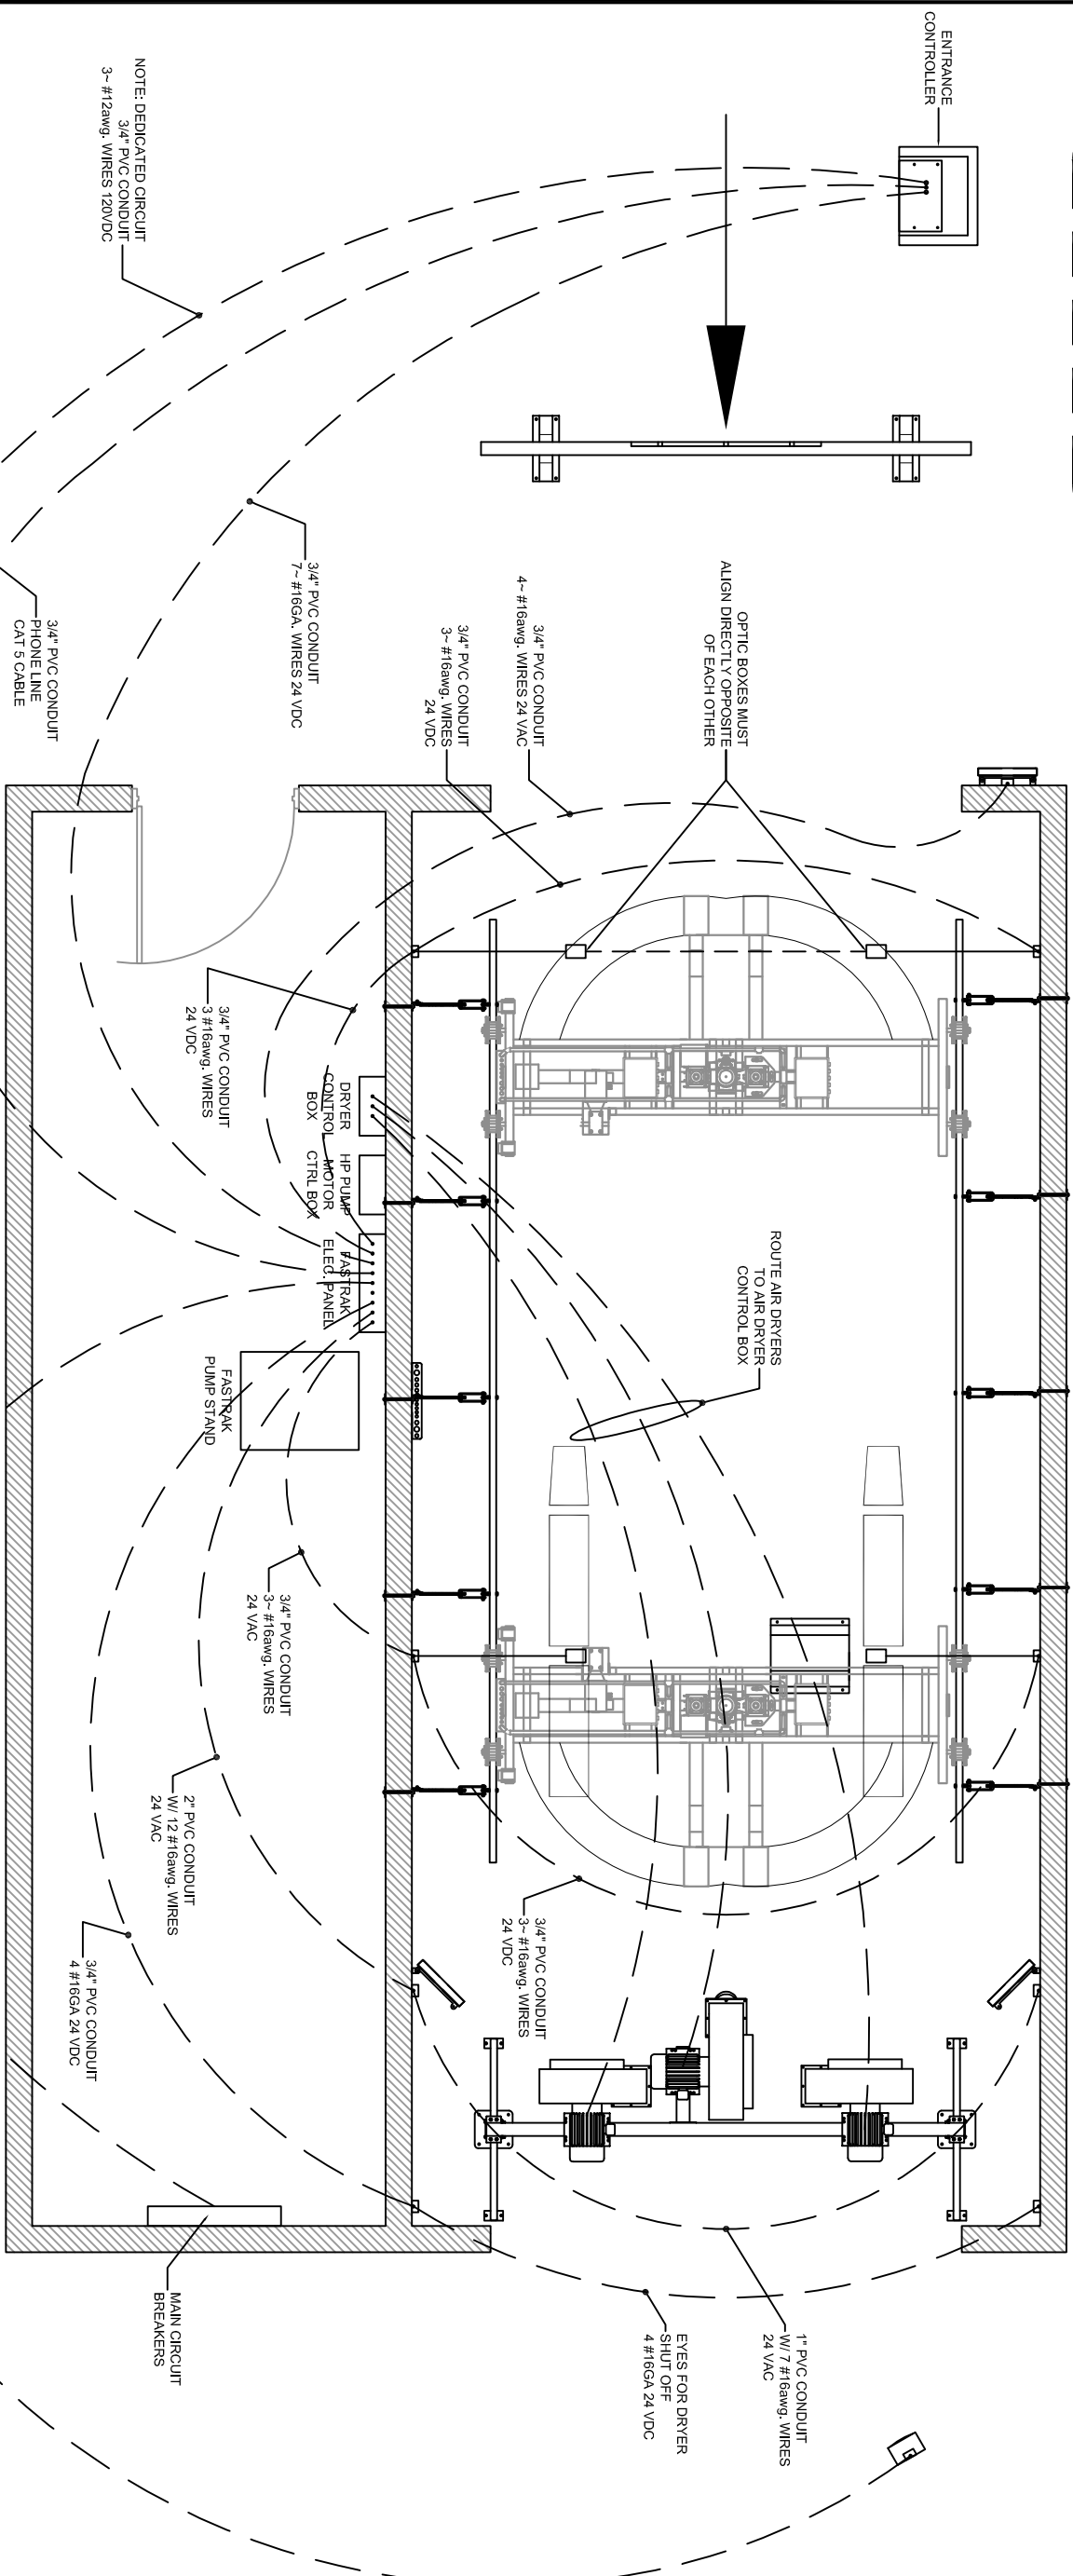

ELECTRICAL NOTES:

- (1) **FASTRAK MAIN CONTROL BOX**
60 AMP 3 PHASE BREAKER
+ NEUTRAL + GROUND
- (2) **HIGH PRESSURE PUMP MOTOR CONTROL BOX**
REQUIRES 100 AMP BREAKER
3 PHASE 208 / VOLT
- (3) **AIR DRYER CONTROL BOX**
3-CIRCUITS 60 AMP BREAKERS 208 V 3 PHASE
FROM ELECTRICAL PANEL
1 - CIRCUIT FOR ALL 3 MOTORS (OPTIONAL)

*** ELECTRICIAN TO VERIFY WITH OWNER ***

FASTRAK W/ 24' TRACK RAIL

CONFIRM EQUIPMENT
ORDER WITH OWNER

REVISIONS ENGINEER SEAL OR APPROVAL:	OWNER: COLEMAN HANNA CAR WASH SYSTEMS, LLC 5842 WEST 34TH STREET HOUSTON, TX 77092			
	SHEET NAME: FASTRAK ELECTRICAL CONDUIT RUNS			
	SCALE: AS SHOWN	DATE: 06/04/2014	DRAWN BY: JTREVINO	APPROVED BY:
	DRAWING A.K.O.:	EQUIPMENT A.K.O.:	FILE NAME: T:\W-FASTRAK\FT3.0.dwg	T:\W-FASTRAK\FT3.0.dwg

COLEMAN HANNA
CARWASH SYSTEMS LLC

AN O'HANRAHAN COLEMAN COMPANY

5842 WEST 34TH STREET
HOUSTON, TEXAS 77092
PH: 800-999-9878 FAX: 713-225-8876
www.colemanhanna.com

SHEET:
FT3.0